 



DO NOT SCALE
REMOVE ALL BURRS AND SHARP EDGES

1st ANGLE
PROJECTION




UNLESS NOTED OTHERWISE, ALL DIMENSIONS
ARE IN MILLIMETRES

THIS DESIGN IS COPYRIGHT AND THE DRAWING IS THE
PROPERTY OF UNISTRUT LIMITED AND IS TO BE USED
BETWEEN CLIENTS AND THEMSELVES ONLY.

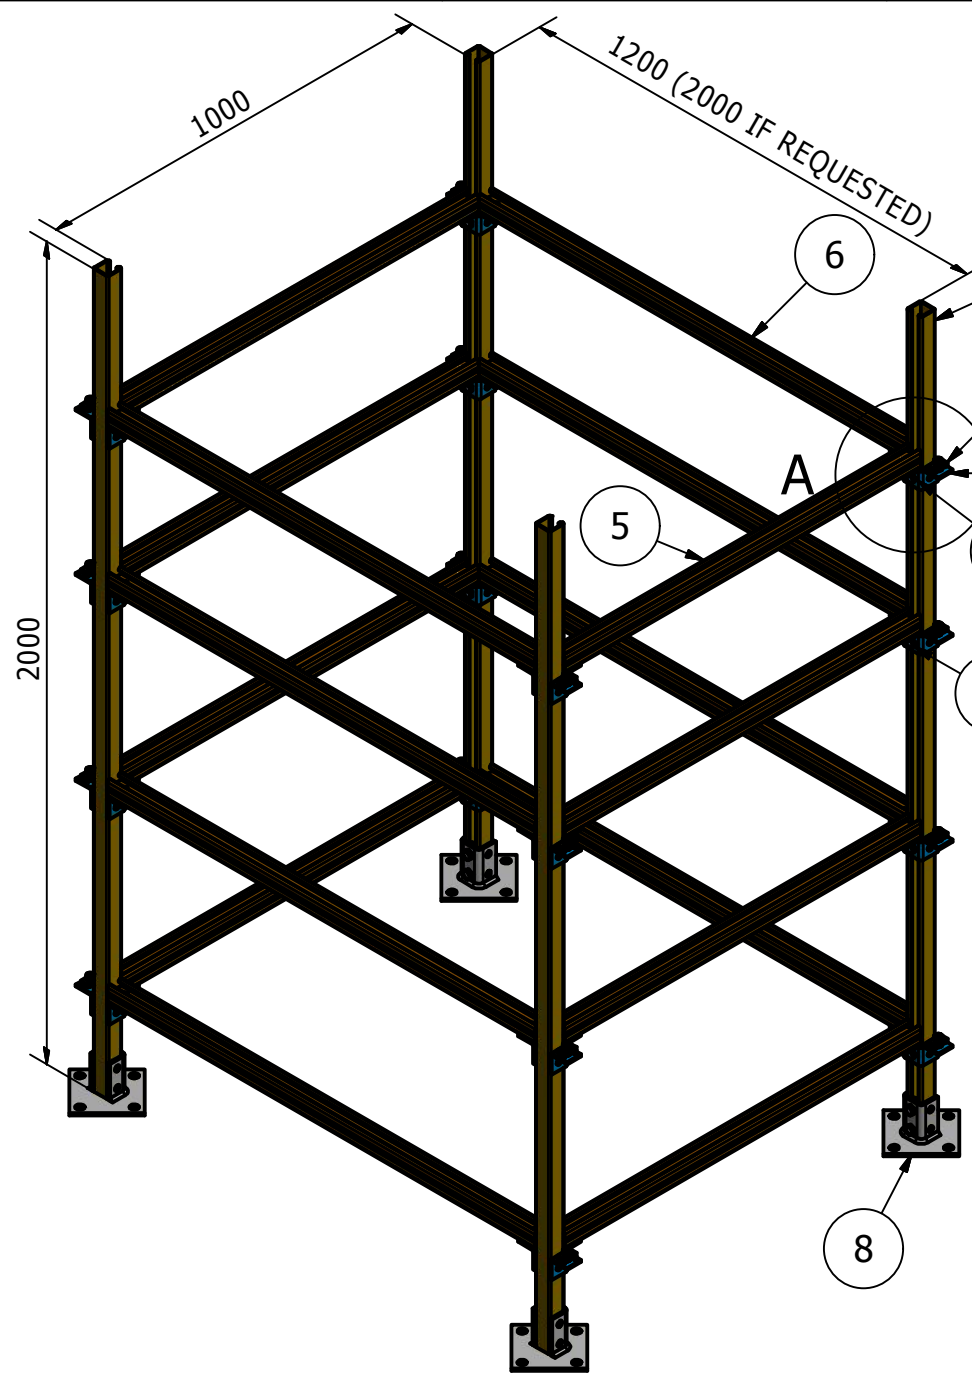

NOTES:

A (1 : 4)

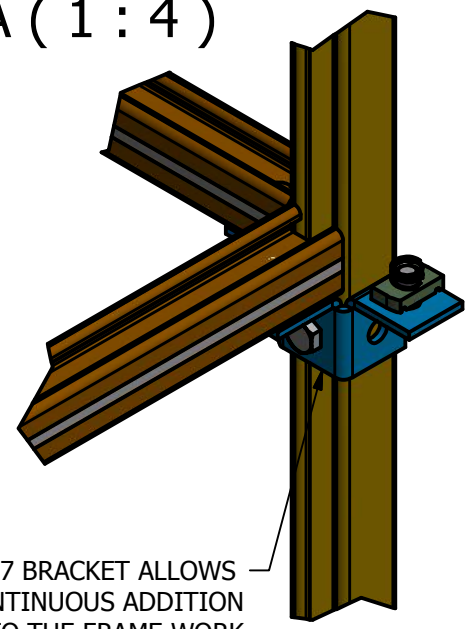

P2227 BRACKET ALLOWS
CONTINUOUS ADDITION
TO THE FRAME WORK
(AS THE REQUESTED
DRAWING INDICATES)

PARTS LIST		
ITEM	QTY	PART NUMBER
1	48	PNL12A
2	24	PNL12
3	72	933312X25
4	4	P1000x2000
5	8	P3301x1000
6	8	P3301x1200
7	16	P2227
8	4	P2072A

REV & DATE	DESCRIPTION	CHK'D & DATE



Delta Point, Greets Green Road,
West Midlands, B70 9PL
Tel: 0121 580 6300
Fax: 0121 580 6366

FM 825 - BS EN ISO 9001



PART No.s :	MATERIAL:	FINISH:	TOLERANCES U.N.O.
			DIMS. ±
			ANGLES ±

DRAWN/DATE: B.S 13/08/15	CHECKED/DATE: C.B.J 13/08/15
DISK No:	


SCALE:
N.T.S.

TITLE: POWER PLANT TEMA GHANA FRAME

PART No:	WS10664	REV:
----------	---------	------

DO NOT SCALE
REMOVE ALL BURRS AND SHARP EDGES

 
1st ANGLE
PROJECTION



UNLESS NOTED OTHERWISE, ALL DIMENSIONS
ARE IN MILLIMETRES

THIS DESIGN IS COPYRIGHT AND THE DRAWING IS THE
PROPERTY OF UNISTRUT LIMITED AND IS TO BE USED
BETWEEN CLIENTS AND THEMSELVES ONLY.

NOTES:

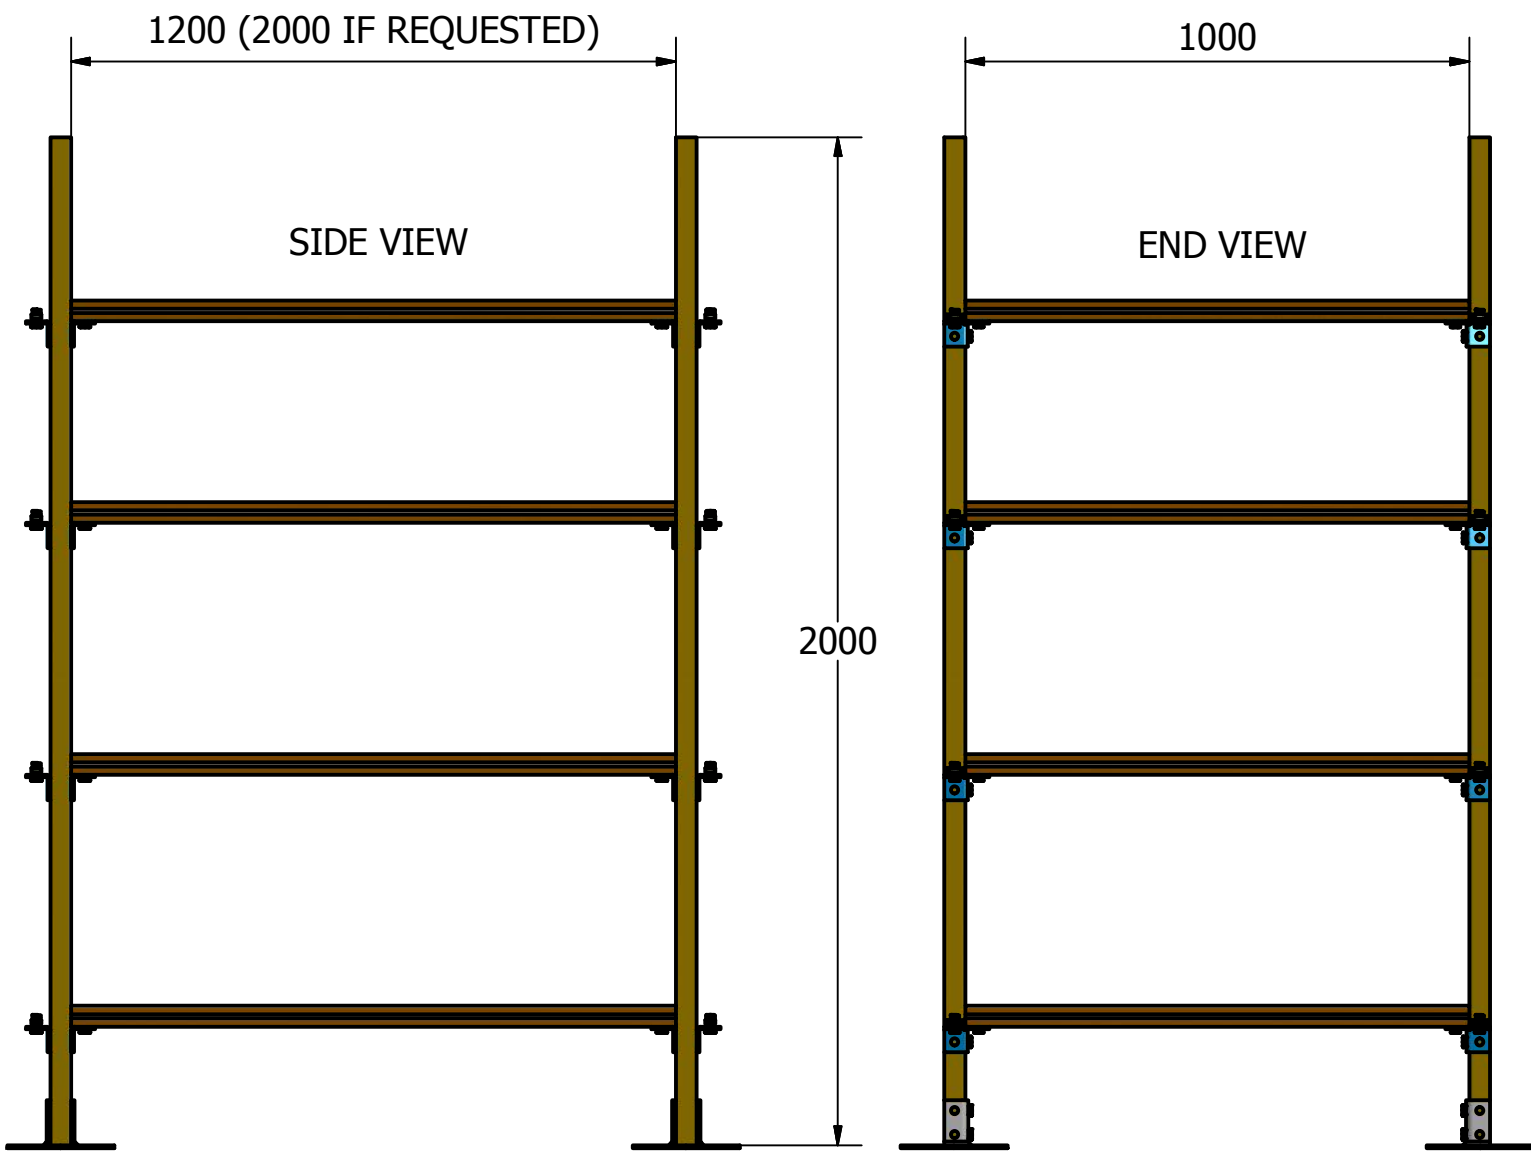

REV & DATE	DESCRIPTION	CHK'D & DATE
------------	-------------	--------------



Delta Point, Greets Green Road,
West Midlands, B70 9PL
Tel: 0121 580 6300
Fax: 0121 580 6366

FM 825 - BS EN ISO 9001



PART No.s :	MATERIAL:	FINISH:	TOLERANCES U.N.O.
			DIMS. ±
			ANGLES ±

DRAWN/DATE: B.S 13/08/15	CHECKED/DATE: C.B.J 13/08/15
DISK No:	

SCALE:
N.T.S.

TITLE: POWER PLANT TEMA GHANA FRAME

PART No: **WS10664**

REV.